

Oakleigh Cannons FC – Jack Edwards Reserve

EMERGENCY & EVACUATION PLAN

LEGEND

EXIT POINTS



ASSEMBLY POINTS



DEFIBRILATOR



FIRST AID ROOM



FIRE EXTINGUISHER




FIRE BLANKET



AMBULANCE BAY



EVACUATION PATH

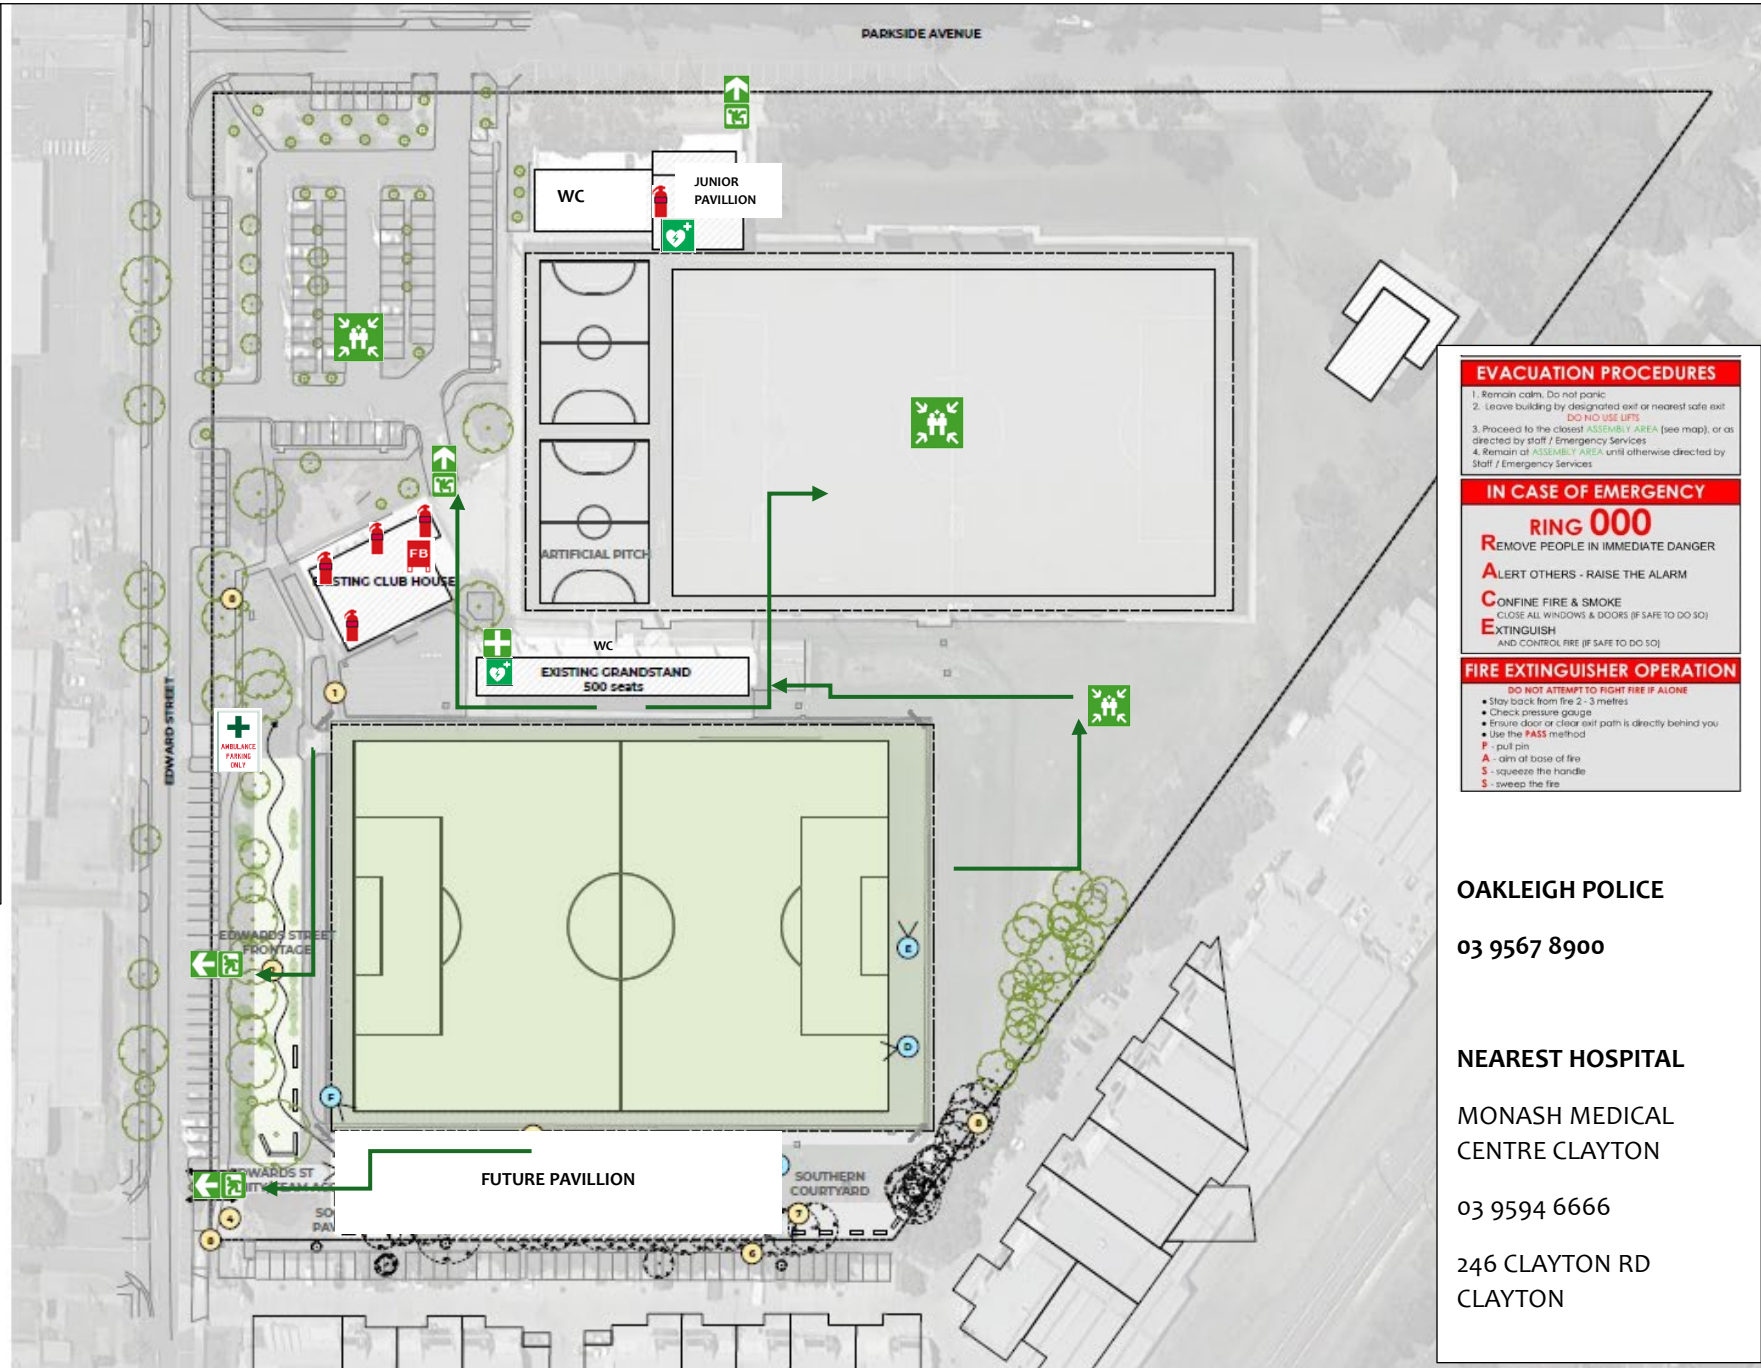

EVACUATION PROCEDURES

1. Remain calm, Do not panic
2. Leave building by designated exit or nearest safe exit
DO NOT USE LIFTS
3. Proceed to the closest ASSEMBLY AREA (see map), or as directed by staff / Emergency Services
4. Remain at ASSEMBLY AREA until otherwise directed by Staff / Emergency Services

IN CASE OF EMERGENCY

RING 000

- R**EMOVE PEOPLE IN IMMEDIATE DANGER
ALERT OTHERS - RAISE THE ALARM
CONFINE FIRE & SMOKE
CLOSE ALL WINDOWS & DOORS (IF SAFE TO DO SO)
EXTINGUISH
AND CONTROL FIRE (IF SAFE TO DO SO)

FIRE EXTINGUISHER OPERATION

- DO NOT ATTEMPT TO FIGHT FIRE IF ALONE**
- Stay back from fire 2 - 3 metres
 - Check pressure gauge
 - Ensure door or clear exit path is directly behind you
 - Use the **PASS** method
 - P** - pull pin
 - A** - aim at base of fire
 - S** - squeeze the handle
 - S** - sweep the fire

OAKLEIGH POLICE

03 9567 8900

NEAREST HOSPITAL

MONASH MEDICAL
CENTRE CLAYTON

03 9594 6666

246 CLAYTON RD
CLAYTON

SITE PLAN

Scale 1:500 @ A1 / 1:1000 @ A3